

FOR INFORMATION

Legend:

- Proposed Development Boundary
- Proposed Road Development
- Proposed Site Extent
- Proposed Lighting Location
- Proposed Column Pattern
4322 lm LED mounted on 6m high columns

San áireamh tá sonraíocht Shuirbhíreacht Ordnáis Éireann arna atáirgeadh faoi Cheadúnas OSI Uimh. 2010/18CCMA/Comhairle Contae na Gaillimhe. Sárúonn atáirgeadh neamhdáraithe cóipcheart Shuirbhíreacht Ordnáis Éireann agus Rialtas na hÉireann. © Suirbhíreacht Ordnáis Éireann, 2010.

© Suirbhíreacht Ordnáis Éireann. Gach ceart ar chosaint.
Uimhir cheadúnais 2010/18CCMA/Comhairle Contae na Gaillimhe.

Includes Ordnance Survey Ireland data reproduced under OSI Licence number 2010/18CCMA/Galway County Council.
Unauthorised reproduction infringes Ordnance Survey Ireland and Government of Ireland copyright. © Ordnance Survey Ireland, 2010.

© Ordnance Survey Ireland. All rights reserved. Licence number 2010/18CCMA/Galway County Council.

Clients

Comhairle Chontae na Gaillimhe
Galway County Council

An Roinn Iompair
Turasoireacht agus Spóirt
Department Transport, Tourism and Sport

N6
Galway City
Transport Project

TIIP
Bonnasair Iompair Éireann
Transport Infrastructure Ireland

Consultant

ARUP

Corporate House
City East Business Park
Ballybrit, Galway, Ireland.

Tel +353 (0)91 460675
www.N6GalwayCity.ie
www.arup.ie

Job Title
N6 Galway City Ring Road

Scale
1:200 @ A1

Date:
February 2018

I3	28/09/2018	LD	HK	EMC
I2	23/03/2018	AG	HK	EMC
I1	22/02/2018	KJ	HK	EMC
Issue	Date	By	Chkd	Appd


Drawing Title
Galway Racecourse Tunnel Services
Building - Proposed Lighting Layout
Sheet 16 of 17

Drawing Status
For Information

Job No
233985

Drawing No
GCOB-3000-D-215

Issue
13

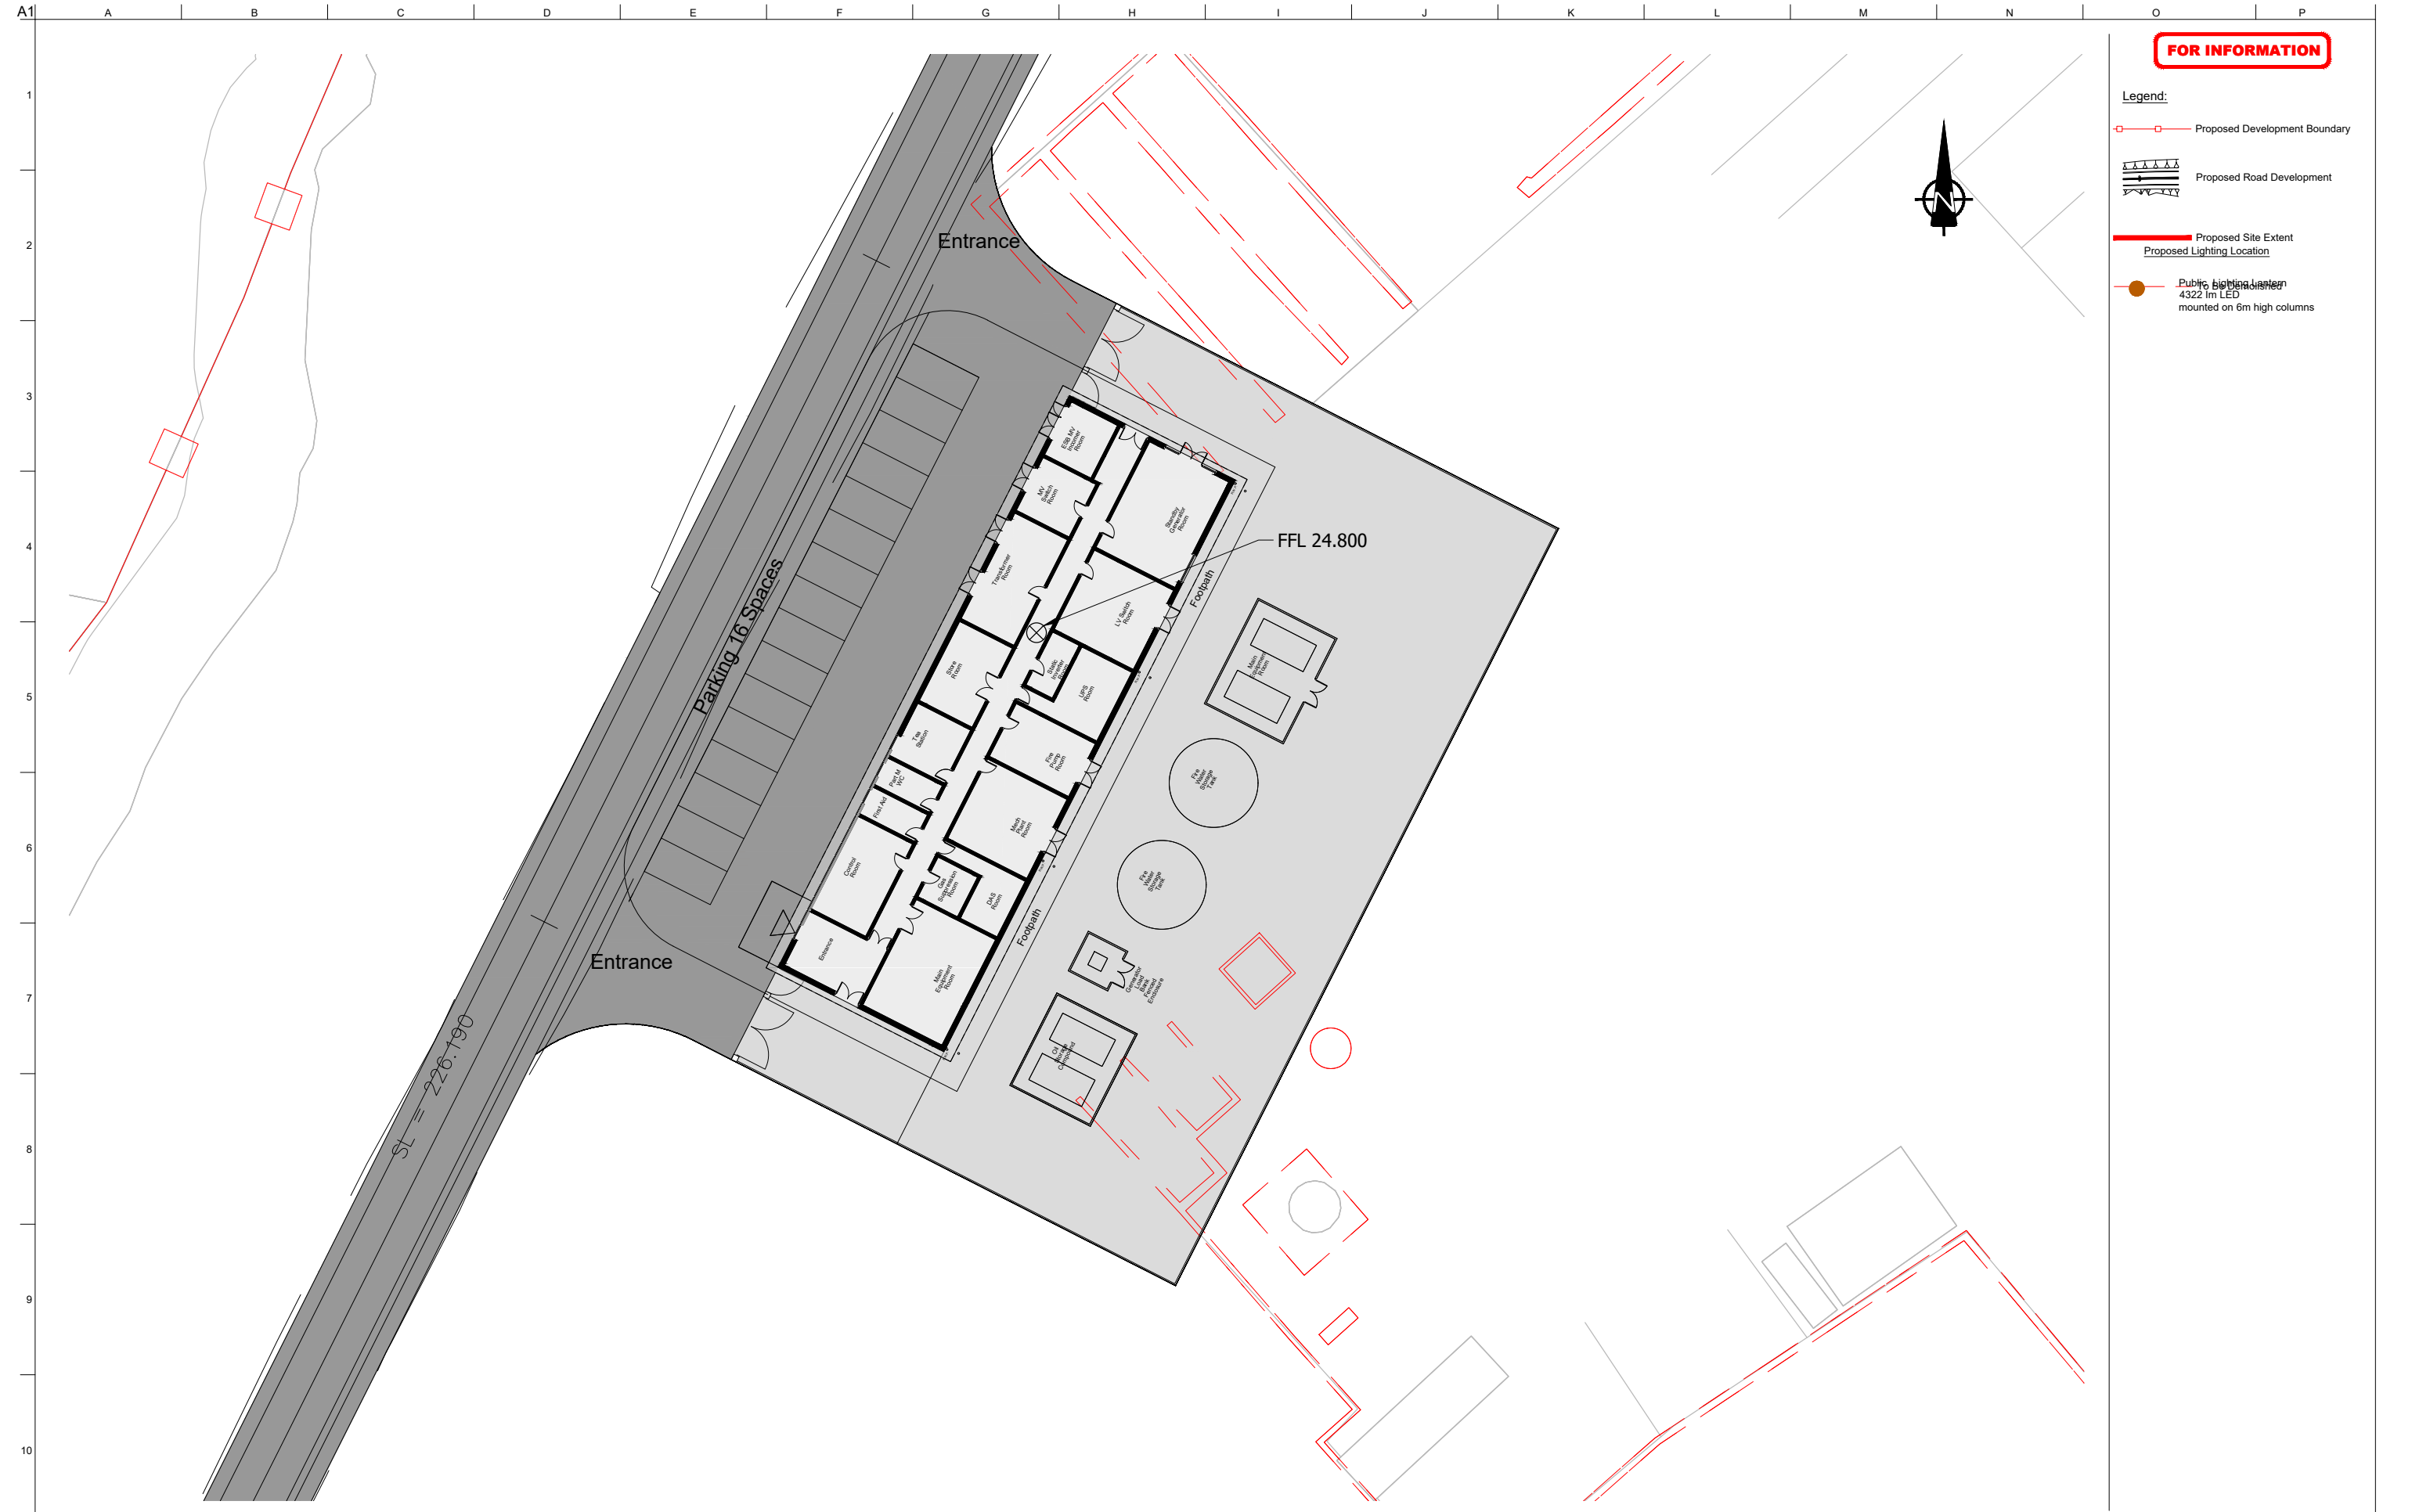

FOR INFORMATION

- Legend:**
- Proposed Development Boundary
 - Proposed Road Development
 - Proposed Site Extent
 - Proposed Lighting Location
 - Public Lighting Pole
4322 lm LED
mounted on 6m high columns



San áireamh tá sonraíocht Shuirbhíreachtú Ordnáis Éireann arna atáirgeadh fós Cheadúnas OSI Uimh. 2010/18CCMA/Comhairle Contae na Gaillimhe. Sírtaíonn atáirgeadh neamhdaraithe cóipeacht Shuirbhíreachtú Ordnáis Éireann agus Rialtas na hÉireann. © Suirbhíreachtú Ordnáis Éireann, 2010.

© Suirbhíreachtú Ordnáis Éireann. Gach ceart ar chosaint.
Uimhir cheadúnais 2010/18CCMA/Comhairle Contae na Gaillimhe.

Includes Ordnance Survey Ireland data reproduced under OSI Licence number 2010/18CCMA/Galway County Council.
Unauthorised reproduction infringes Ordnance Survey Ireland and Government of Ireland copyrights. © Ordnance Survey Ireland, 2010.

© Ordnance Survey Ireland. All rights reserved. Licence number 2010/18CCMA/Galway County Council.

Clients

Comhairle Chontae na Gaillimhe
Galway County Council

An Roinn Iompair
Turasóireachta agus Spóirt

TII
Bonnáirí Iompair Éireann
Transport Infrastructure Ireland

Consultant

Corporate House
City East Business Park
Ballybrit, Galway, Ireland.

Tel +353 (0)91 460675
www.N6GalwayCity.ie
www.arup.ie

Job Title
N6 Galway City Ring Road

Scale
1:500 @ A1

Date:
February 2018

I3	28/09/2018	LD	HK	EMC
I2	23/03/2018	AG	HK	EMC
I1	22/02/2018	KJ	HK	EMC
Issue	Date	By	Chkd	Appd

Drawing Title
Lackagh Tunnel Services Building
Proposed Lighting Layout
Sheet 17 of 17

Drawing Status

For Information

Job No	Drawing No	Issue
233985	GCOB-3000-D-216	13